

REVISIONS:


DRAWING TITLE:

LIGHTING  
PLAN

THIS DRAWING IS AN INSTRUMENT OF THE ARCHITECT'S SERVICES AND IS HIS SOLE PROPERTY, AND SHALL NOT BE REPRODUCED, USED OR OTHERWISE ALTERED WITHOUT THE WRITTEN PERMISSION OF THE ARCHITECT ©

PROJECT NO.  
092471

ISSUE DATES:  
10-30-2009 PERMIT  
11-3-2009

APPROVED BY:

TENANT: \_\_\_\_\_

DATE: \_\_\_\_\_

LANDLORD: \_\_\_\_\_


DATE: \_\_\_\_\_

DRAWING NO.

E2

SHEET NO.

7 OF 10

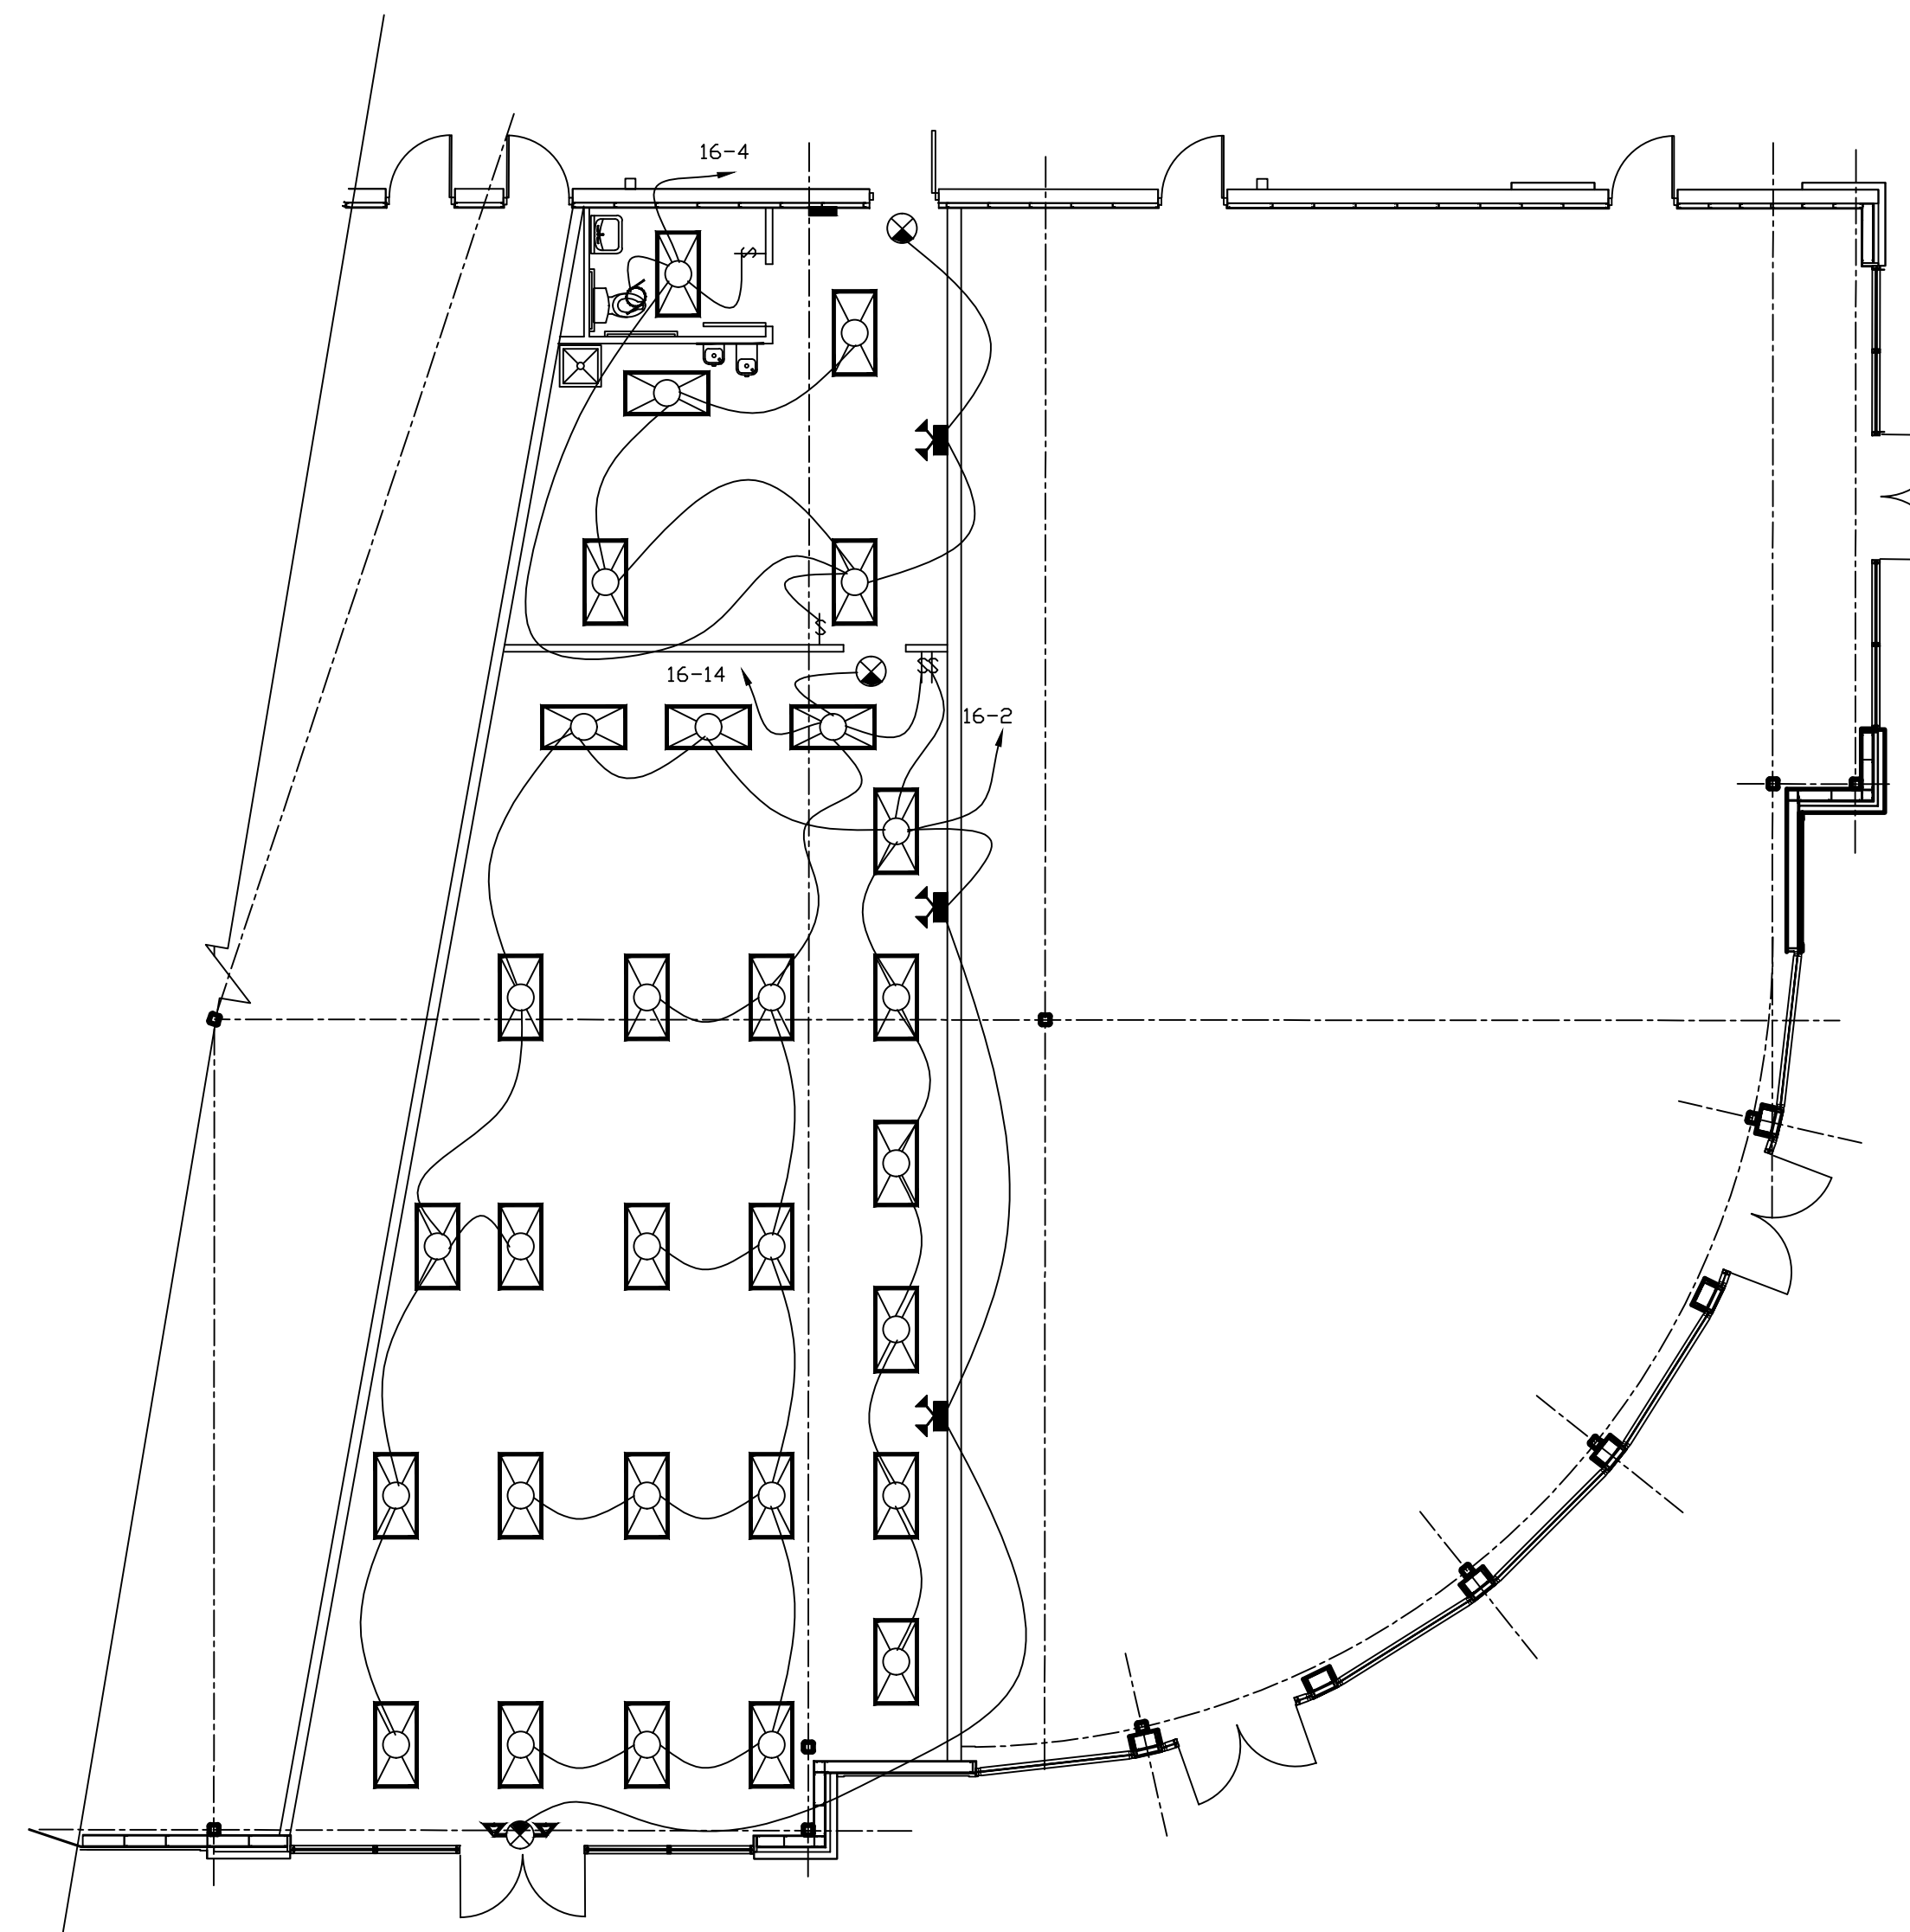

LIGHTING PLAN

SCALE: 1/8"=1'-0"

## LIGHT FIXTURE SCHEDULE

SYMBOLS	DESCRIPTION	MANUFACTURER & NO.	LAMPS
	NEW 2X4 RECESSED FLUORESCENT LIGHT FIXTURE	*LIGHTOLIER* MODEL #SPS2-G-FS-VA-4-32-UNV	FOUR F32-T8 PHILLIPS F32T8/TL/735
	NEW EXIT LIGHT WITH BATTERY PACK	*LIGHTOLIER* MODEL #LL-N-U- --W (COLOR OF LETTERING PER LOCAL CODE) MATCH EXISTING IF ANY IS EXISTING, REMOVE AND REUSE THOSE NOT SHOWN ON THE PLAN	INCLUDED W/ FIXTURE MAX. 5W PER SIDE
	NEW EMERGENCY LIGHT WITH BATTERY PACK	*LIGHTOLIER* MODEL #E8-W	TWO-5.4W (MIN. 90 MIN. ILLUMINATION BATTERY) INCLUDED WITH FIXTURE
	EXISTING COMBINATION EXIT AND EMERGENCY LIGHT		
	LIGHT SWITCH	MATCH BUILDING STANDARD	

NOTES: 1-CONNECT EXIT AND EMERGENCY LIGHTS TO LINE SIDE OF LIGHT FIXTURE SWITCH IN THE SAME AREA. WIRE LIGHT FIXTURES SHOWN CONNECTED AS SUCH.  
2-INFORMATION REGARDING EXISTING CIRCUITS, WIRING, CONNECTIONS, ETC. SHOWN SHALL BE SITE VERIFIED. SITE VISIT PRIOR TO BIDDING AND VERIFY ALL EXISTING INFORMATION PROVIDED. NOTIFY THE ARCHITECT OF ANY DISCREPANCIES PRIOR TO THE BIDDING.  
3-REMOVE ALL TEMPORARY LIGHTS AND ALL RELATED WIRING TO PANEL CONNECTED.

CERTIFICATION:  
I, ALI R ZARGARIAN, AIA, CERTIFY THAT THESE DOCUMENTS WERE PREPARED OR APPROVED BY ME AND I AM DULY LICENSED ARCHITECT UNDER THE LAWS OF THE STATE OF MARYLAND, LICENSE NO. 7627-A, EXPIRATION DATE: 5-16-2011